

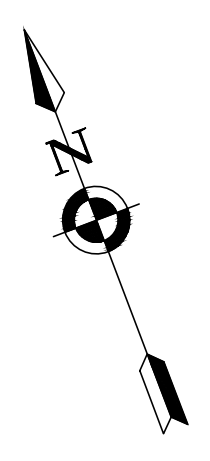
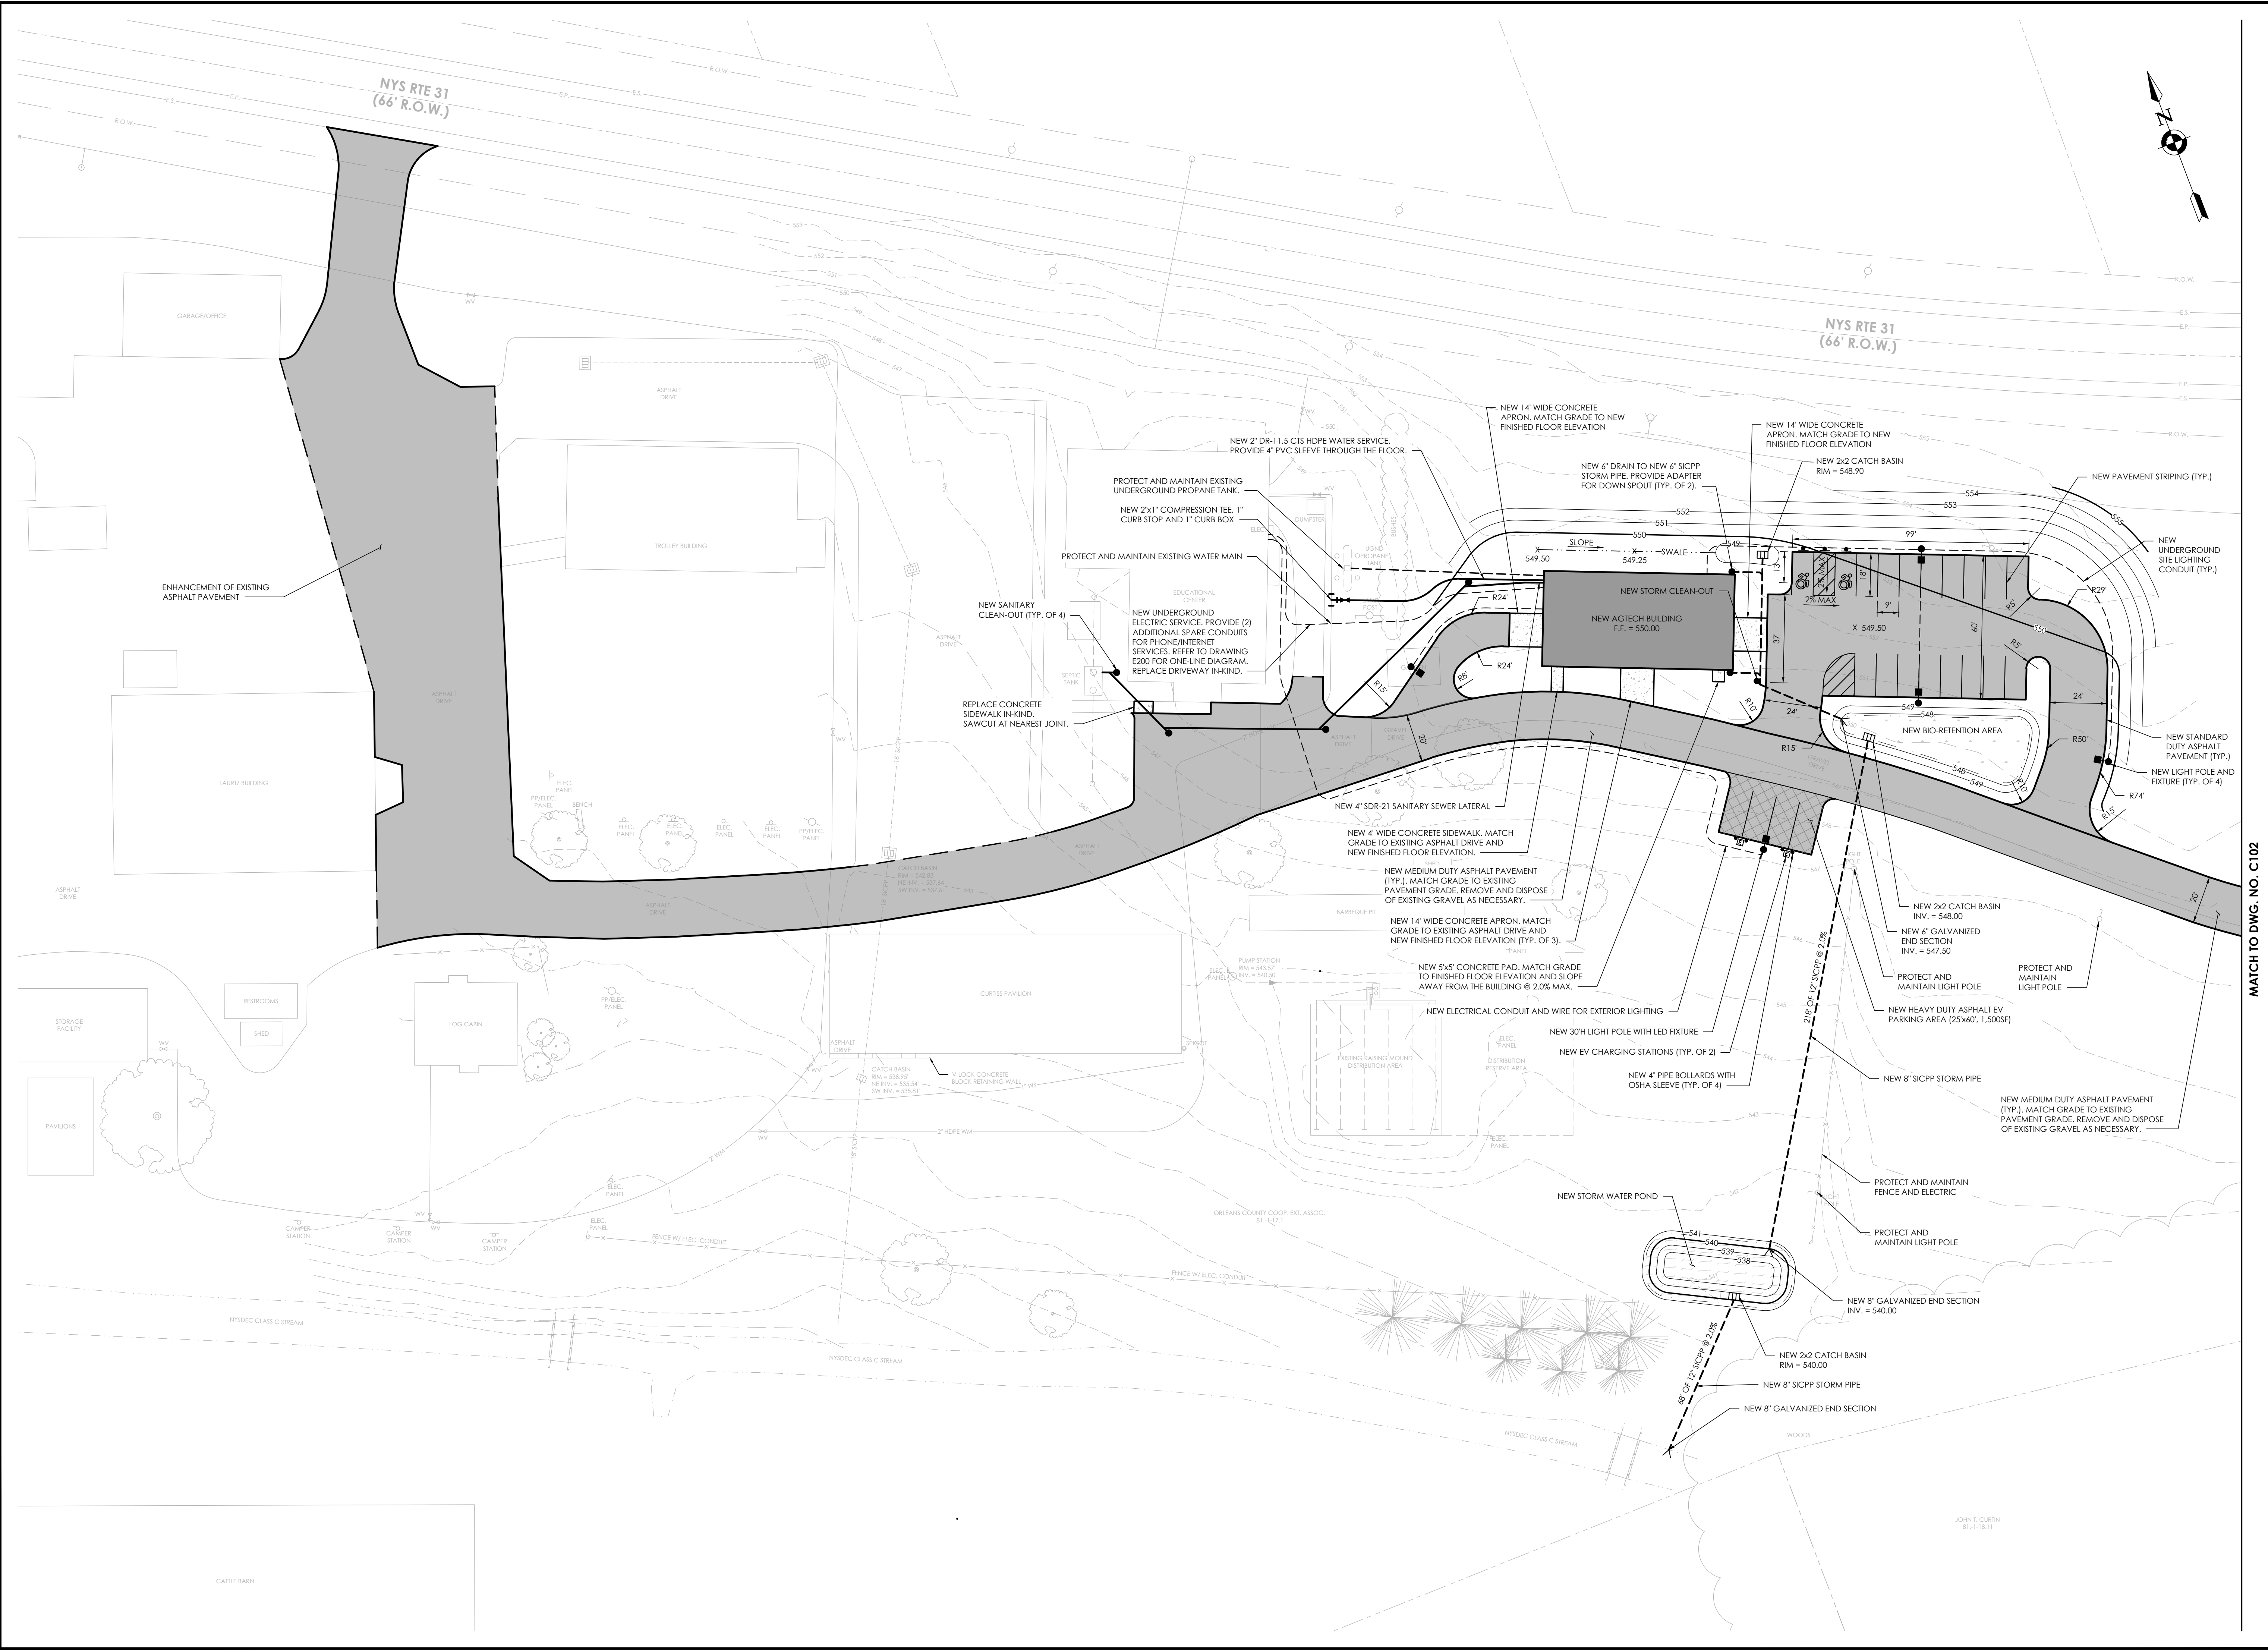


Drawing Name: J:\PROJECTS\Orleans\_Co\CCCE\Bld & Sanitary\Improv\Design\ACAD\Civil\Site\Design\2020\_05\_04.dwg  
 Date last accessed: 1/18/2023 3:16 PM  
 Date last plotted: 1/18/2023 3:17 PM  
 Plotted By: Nick Binnert

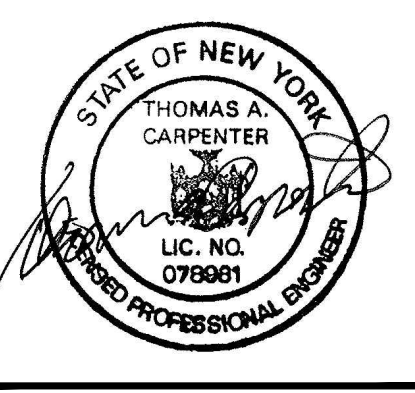

  
**CPLteam.com**  
 ARCHITECTURE • ENGINEERING • PLANNING  
 205 ST. PAUL STREET, SUITE 500  
 ROCHESTER, NEW YORK 14604  
 TEL (800) 274-9000  
 FAX (585) 454-7618

| REVISIONS NO. | DATE | BY | DESCRIPTION |
|---------------|------|----|-------------|
|               |      |    |             |
|               |      |    |             |

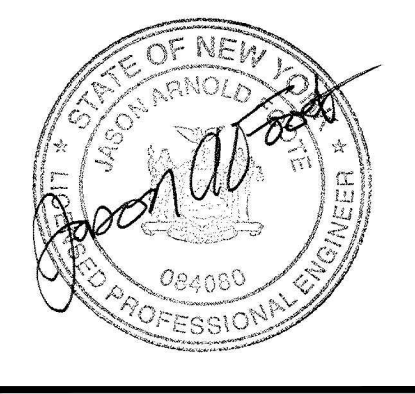

**ORLEANS COUNTY CORNELL COOPERATIVE EXTENSION AGTECH BUILDING**  
 12690 NY-31, ALBION, NY 14411

|                   |       |         |
|-------------------|-------|---------|
| DATE              | DRAWN | CHECKED |
| 01/16/23          | NCB   | JAF     |
| SCALE 1" = 30'-0" |       |         |
| SHEET TITLE       |       |         |
| SITE PLAN         |       |         |

|                |          |
|----------------|----------|
| PROJECT NUMBER | 13608.00 |
| DRAWING NUMBER | C101     |

MATCH TO DWG. NO. C102